

347V LIGHTING LAYOUT
SCALE 1 : 100



CLIENT

DESIGNER

APPROVED

No.	↑	ISSUE NOTES	↓	DATE
No.	↓	REVISION NOTES	↓	DATE
...	

This drawing is the sole property of ELECTEC. Reproduction is not permitted. Only stamped, signed and dated copies of this drawing can be used for construction. Drawings shall be read in conjunction with other project drawings.
This drawing is not to be scaled. Contractor shall check & verify any discrepancies with GEM/WR prior to proceeding with the work.
Contractor must comply with the requirements of applicable codes, bylaws and other authorities having jurisdiction.
Electronic versions of this drawing shall not be used without written permission.

PROJECT NAME / TCM DU PROJECT




DRAWING TITLE / ATRE DU CLIENT

DRAWING TITLE

DESCRIPTION	DATE	BY	APP. PRICE
DESIGNED BY			
DRAWN BY			
CHECKED BY			
DATE	AS SHOWN		
CODE	APPL 03 2009		
PROJECT	484-02-44		
REV. PRICE	XXX		

E2

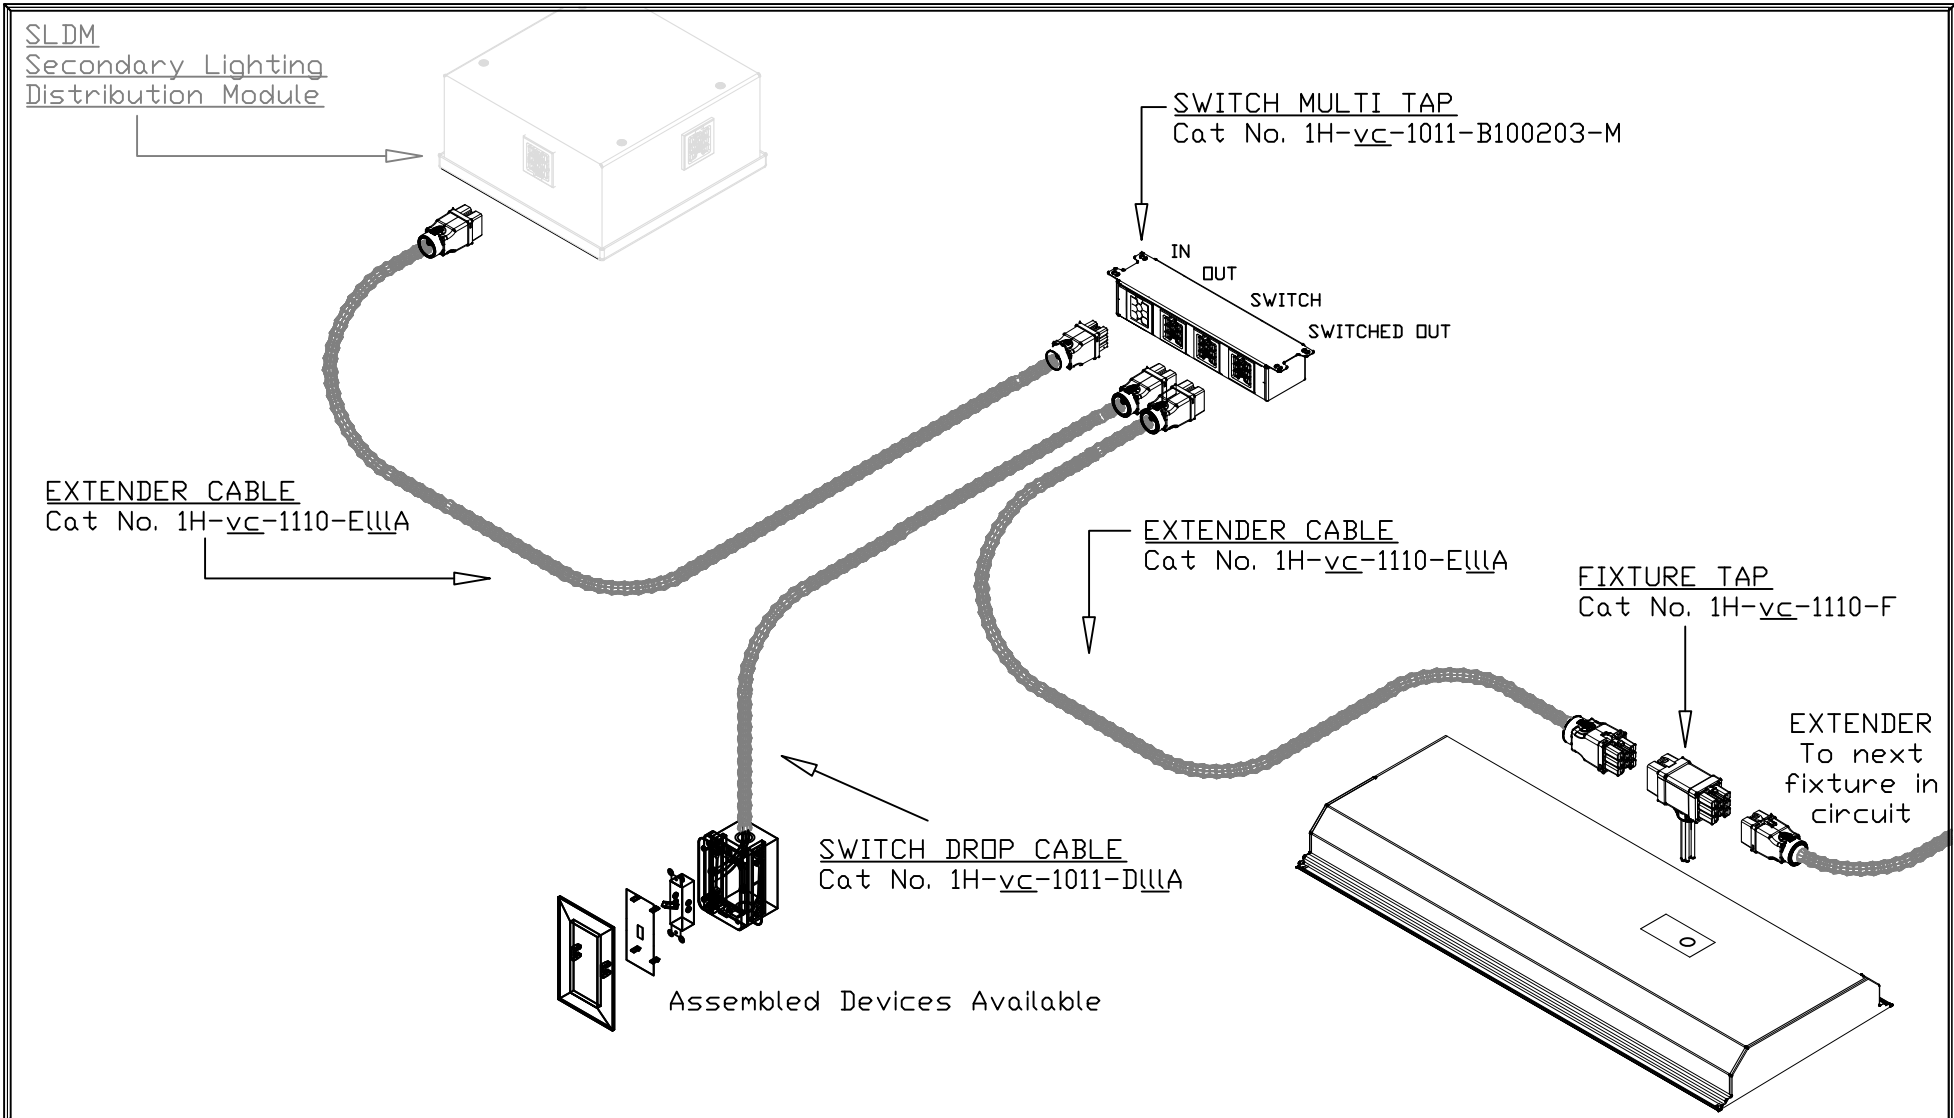

vc	SYSTEM RATING	22	125/250V 20A
		42	277/480V 20A
		62	347/600V 20A
111	CABLE LENGTH		e.g 040 = 4.0m



"EZ-WIRING", "EZ-CABLING", & "ULTRALX" are Trade-marks of **ELECTEC**.
www.electeconline.com

OWNERSHIP OF DOCUMENTS
 This drawing and accompanying information as instrument of service are the property of **ELECTEC**.
 Reproduction or use in whole or in part in any form whether the work for which they are presented is executed or not is forbidden without the express written permission of **ELECTEC**.

EZ-Wiring H-Series
 Lighting Application
 Standard Single Pole
 Switching Detail

DRAWN BY: C.P	APPROVED: D.H.
DATE: 7.19.12	SCALE: N.T.S.


R.2

EXTENDER CABLE
 Cat No. 1H-vc-lngo-E11A
 (from previous fixture)

FIXTURE DROP
 Cat No. 1H-vc-lngo-Fc11A
 (provides connection to suspended luminaires)

SUPPORT BRACKET (Optional)
 Cat No. FDSB

EXTENDER CABLE
 Cat No. 1H-vc-lngo-E11A
 (to next fixture)

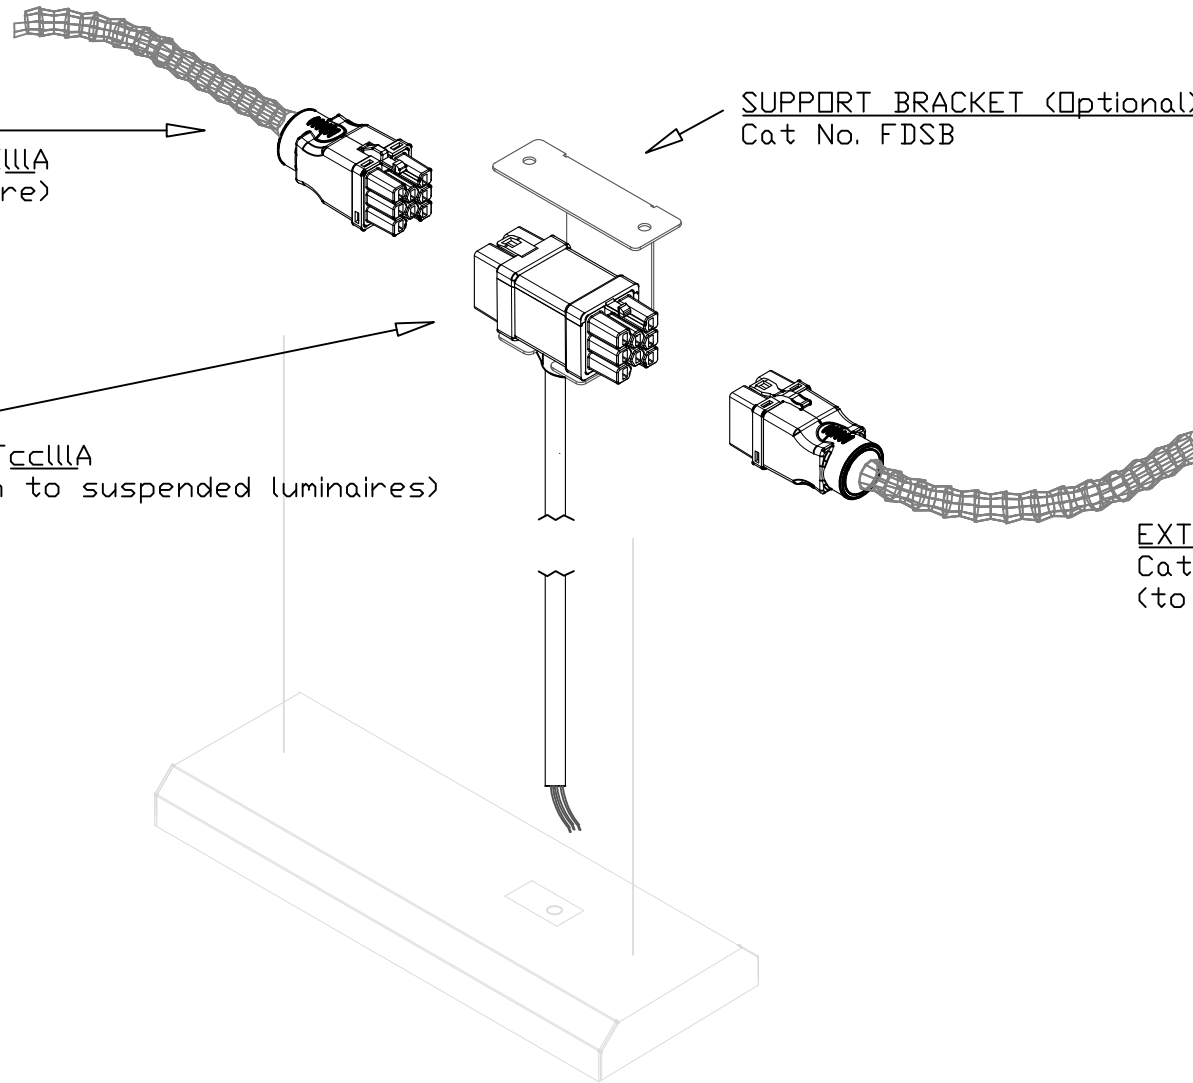

"EZ-WIRING", "EZ-CABLING", & "ULTRALX" are
 Trade-marks of **ELECTEC**.
www.electeonline.com

EZ-Wiring H-Series
 Lighting Application

Hanging Fixture
 Installation Detail

DRAWN BY:
 C.P.

APPROVED:
 D.H.

DATE:
 11.07.11

SCALE:
 N.T.S.

R.0

OWNERSHIP OF DOCUMENTS

This drawing and accompanying information as instrument of service are the property of **ELECTEC**.
 Reproduction or use in whole or in part in any form whether the work for which they are presented is executed or not is forbidden without the express written permission of **ELECTEC**.